


PLUMBING NOTES:
PLUMBING CONTRACTOR TO PLACE ALL PIPING AND FITTINGS IN FIELD PER CURRENT JURISDICTION CODE REQUIREMENTS.

WATER PIPING NOTES:
1. WATER IS SUPPLIED BY A 1" WATER LINE FROM WATER METER.
2. WATER HEATER SHALL BE SUPPLIED WITH A MINIMUM 3/4" COLD LINE.
3. WATER HEATER SHALL HAVE A MINIMUM 3/4" LINE OUT SERVING THE FIXTURES LISTED.
4. ONE 1/2" WATER LINE SHALL FEED NO MORE THAN SIX (6) FIXTURE UNITS.
5. ALL INDIVIDUAL FIXTURE SUPPLIES SHALL HAVE A 1/2" FEED LINE.
6. ICE MAKER SHALL HAVE A MINIMUM 1/4" FEED LINE.
7. LOOPED HOT WATER LINES FOR RECIRCULATION SYSTEM IS NOT REQUIRED.

WASTE WATER PIPING NOTES:
1. FOLLOW ALL MINIMUM PIPE SIZE NOTES.
2. WATER HEATER SHALL BE SUPPLIED WITH A MINIMUM 3/4" COLD LINE.
3. VENTS SHALL EXIT THE ROOF AND EXTEND A MINIMUM 1' ABOVE FINISH SURFACE.
4. PIPES GOING THROUGH FOOTINGS OR UNDER FOOTINGS OR STEM WALLS SHALL BE SLEEVED.
5. PIPE THROUGH FOOTINGS SHALL NOT AFFECT THE STRUCTURAL INTEGRITY OF THE FOOTING. A CONTINUOUS FOOTING SIZED PER THE FOUNDATION PLAN MUST BE ABOVE OR BELOW THE PIPE.
6. VERIFY ALL FINISH FLOOR HEIGHTS IN REGARDS TO SEWER LATERAL TO ASSURE PROPER DRAINAGE FALL.
7. SEWER LATERAL MAY FALL AT A MINIMUM OF 1/4" FOR 3" PIPE AND 1/8" FOR 4" PIPE.

PLUMBING SCHEDULE				
SYMBOL	ITEM	QTY.	WATER SUPPLY FIXTURE UNIT VALUE	TOTAL WATER SUPPLY FIXTURE UNIT VALUE
KIT	KITCHEN SINK	1	1.4	1.4
DJ	DISHWASHER	1	1.4	1.4
W	WASHING MACHINE	1	1.4	1.4
LAV	LAVATORIES	3	.7	2.1
WC	WATER CLOSETS	2	2.2	4.4
HB	HOSE BIBBS	3	2.5	7.5
SHUR	SHOWER	1	1.4	1.4
TUB / SHUR	TUB / SHOWER	1	1.4	1.4
TUB	TUB	1	1.4	1.4
				22.4 TOTAL UNITS

NOTE: 3/4" WIRESSO PIPING FROM WATER METER TO HOUSE

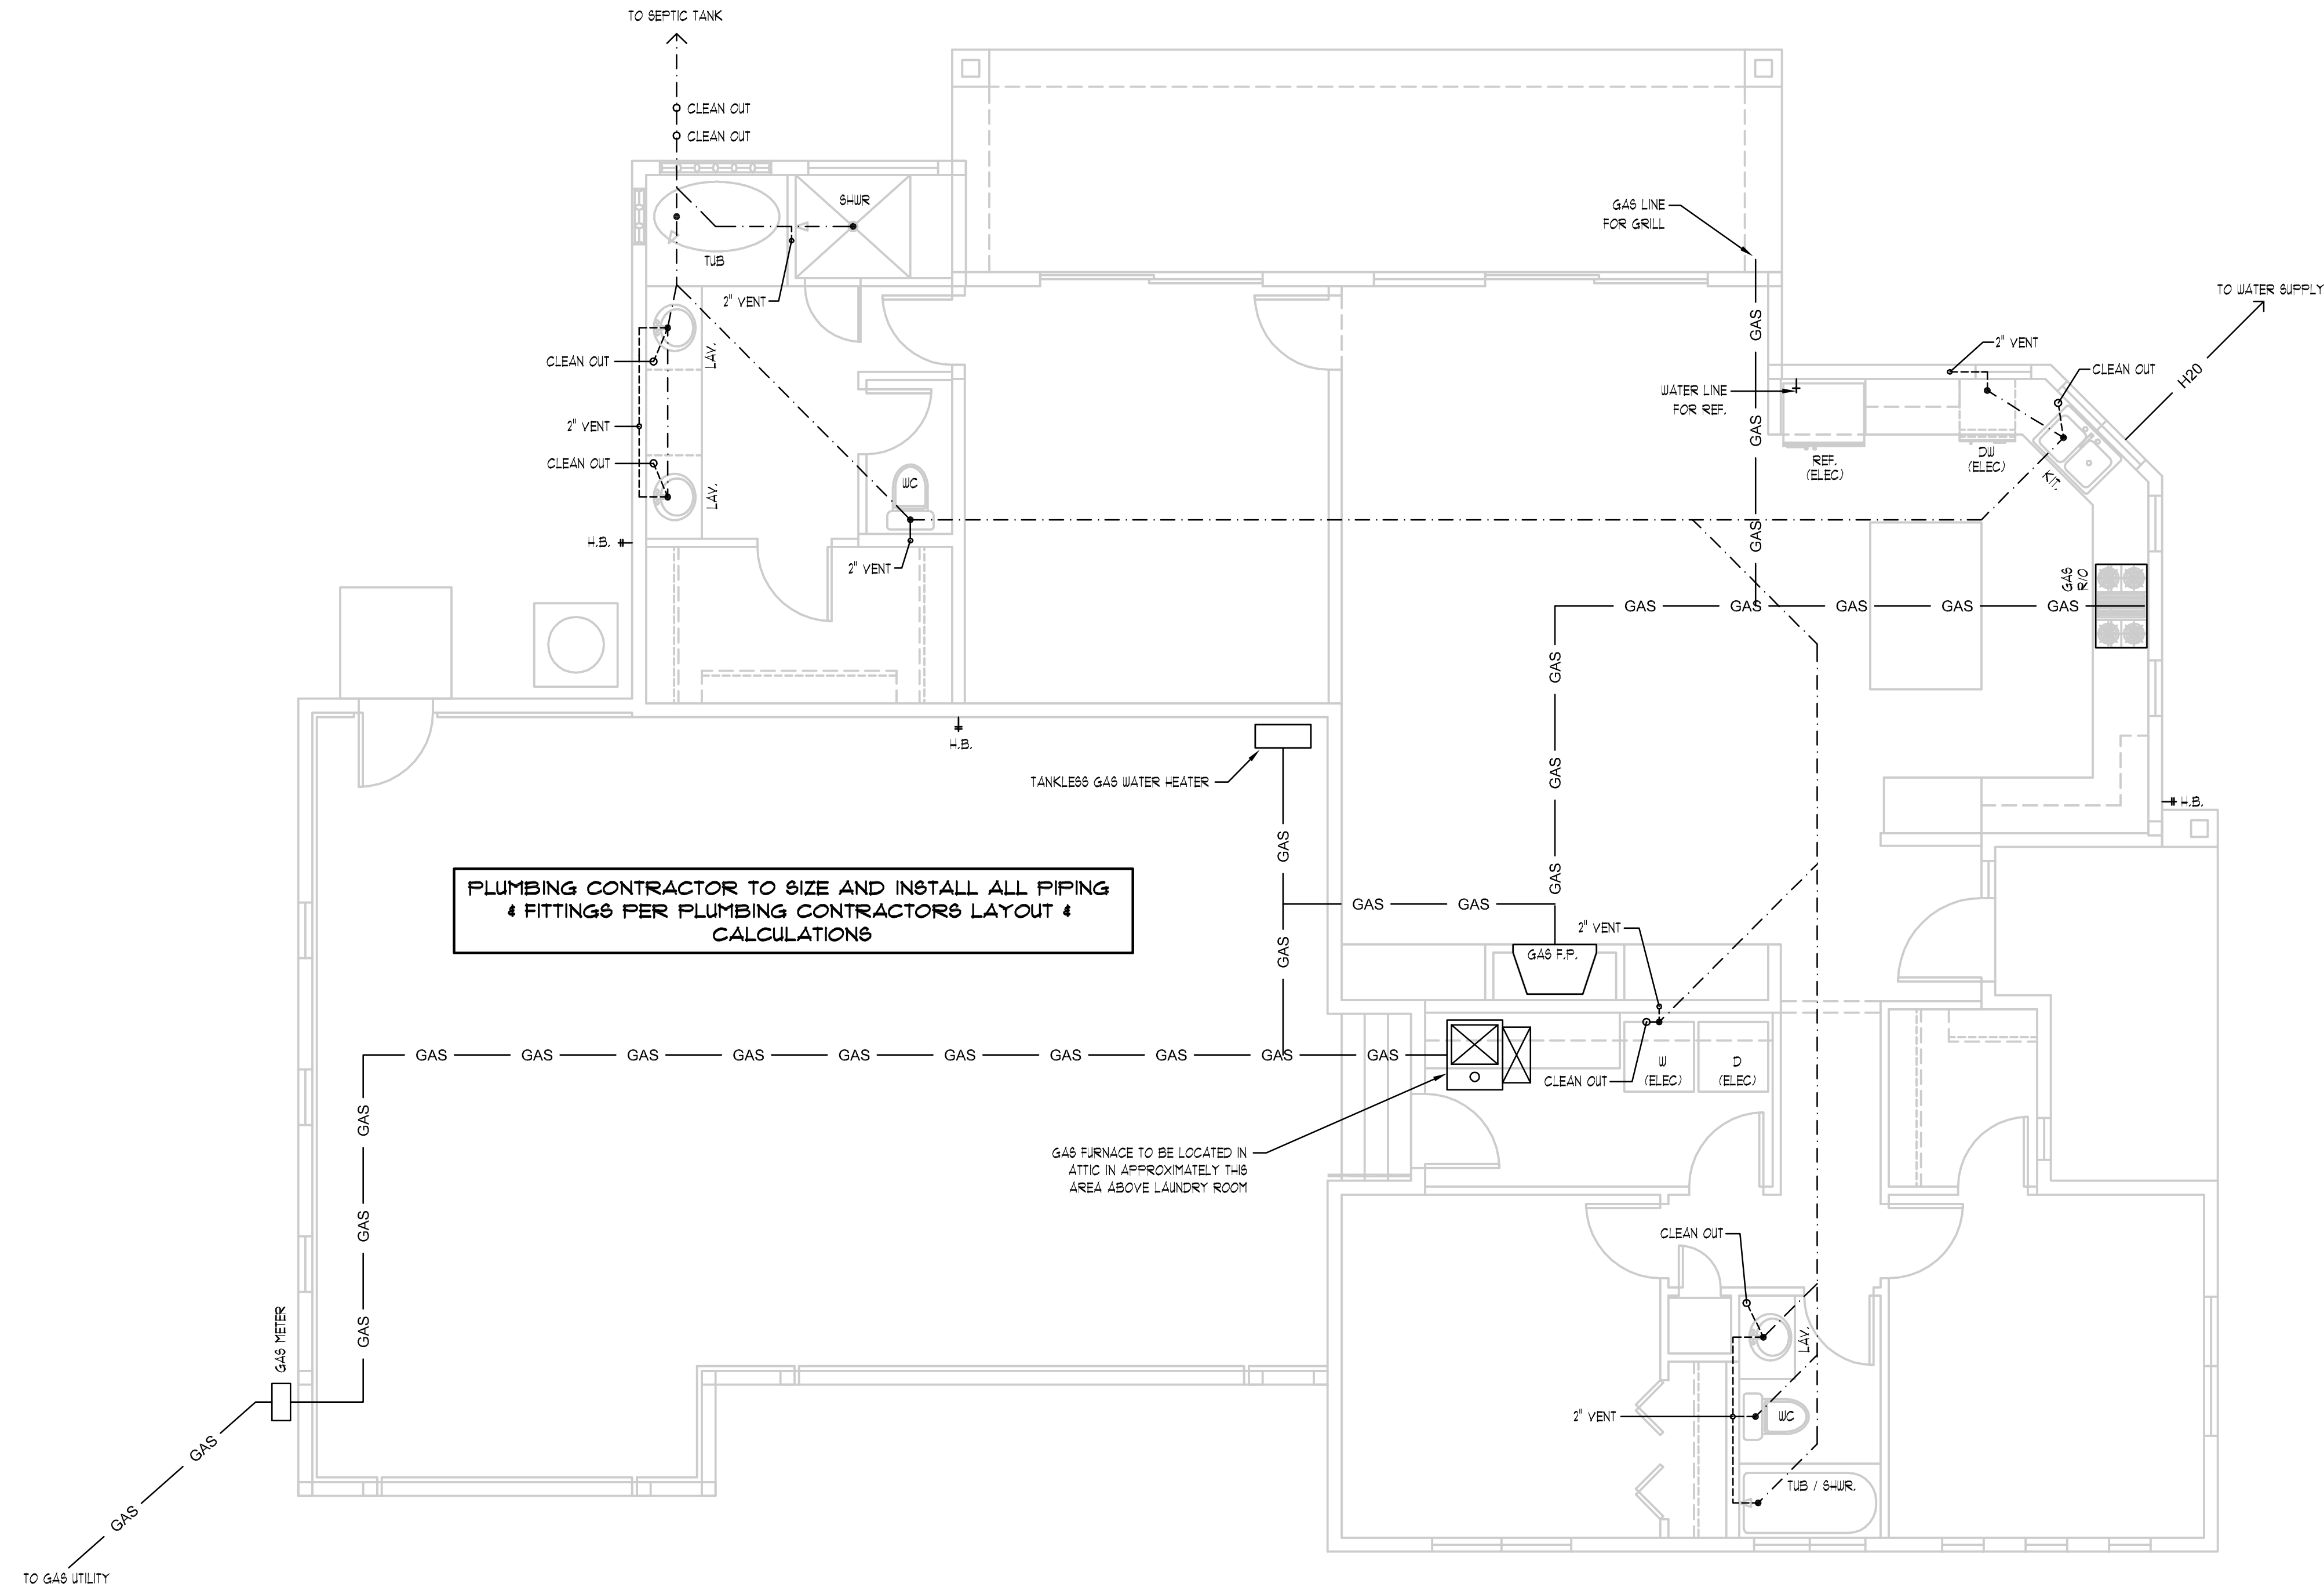

SCHEMATIC PLUMBING FLOOR PLAN
SCALE: 1/4" = 1'-0"

NORTH

HOUSE: 1742 SQ. FT.
GARAGE: 956 SQ. FT.
COVERED ENTRY: 85 SQ. FT.
COVERED PATIO: 231 SQ. FT.